


M:\Projects\TRU01-06 - Millville Square\Construction Docs\DWG\Site Construction\DWG\Site Plan\TRU01-06 FOOD TRUCK STAGING.dwg Nov 04, 2021 - 10:25am, (Sarah)

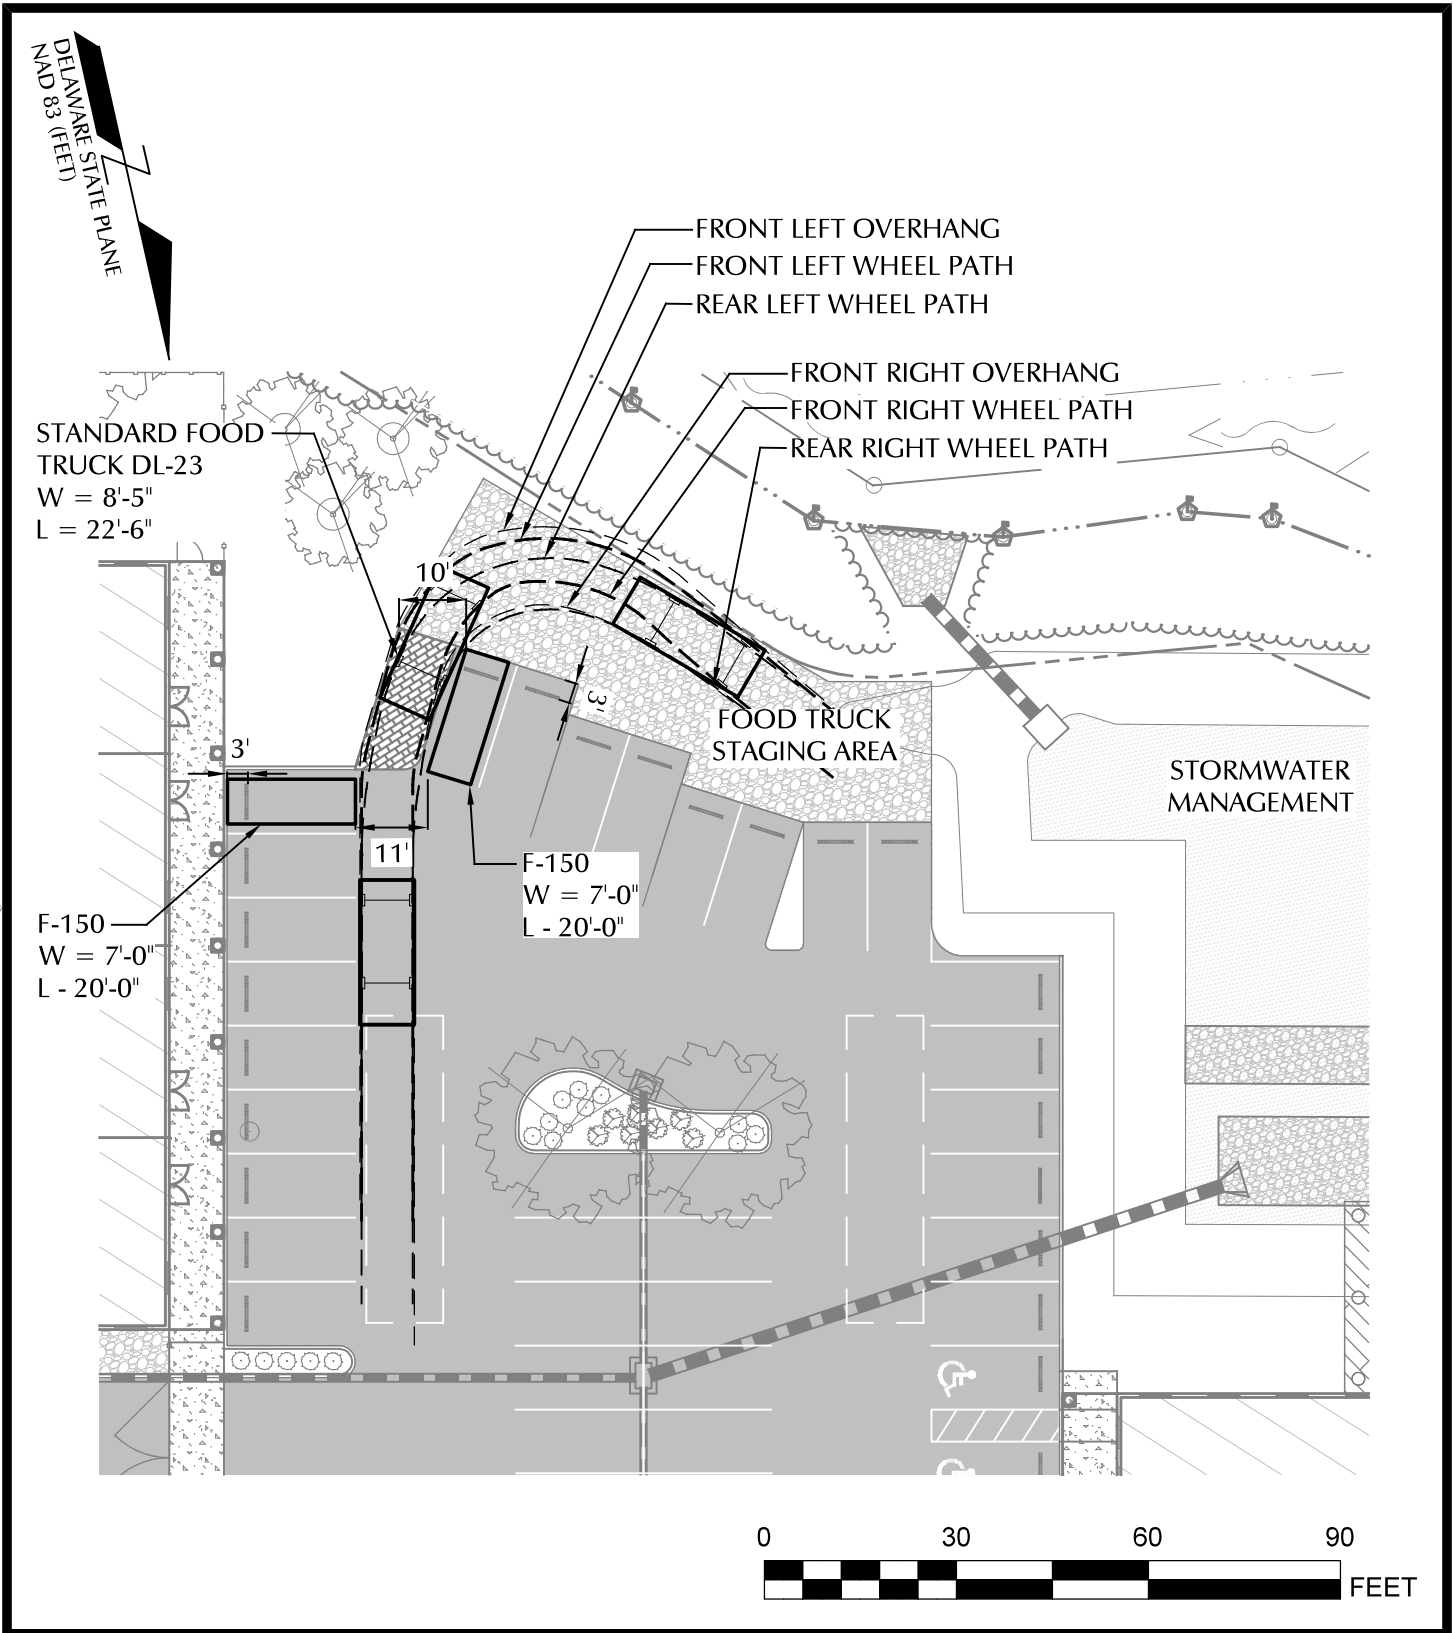

MILLVILLE SQUARE

WHITE CREEK - INDIAN RIVER BAY WATERSHED,
BALTIMORE HUNDRED,
TOWN OF MILLVILLE,
SUSSEX COUNTY, DELAWARE

FOOD TRUCK STAGING EXHIBIT

TAX MAP #134-12.00-350.00
AND #134-12.00-351.00



23318 Cedar Lane Georgetown, Delaware 19947
302.864.8825 info@beaconengineeringllc.com

Date:	11/04/2021
Scale:	1" = 30'
Dwn.By:	SKM
Proj.No.:	TRU01-06
Dwg.No.:	EXHIBIT 1.1