

PLANT SCHEDULE



SYMBOL	QTY	COMMON NAME	BOTANICAL NAME	SIZE
AR	16	WINTER KING HAWTHORNE	CRATAEGUS VIRENS WINTER KING	15 GALLON
CC	21	RED MAPLE	ACER RUBRUM	15 GALLON
TD	15	REDBUD	CERISUS CANADENSIS	15 GALLON
SB	25	BAIRD CYPRESS	TAXODIUM DISCOLORA	15 GALLON
NS	18	AUTUMN BRILLIANCE	AMELIANUM DISCOLORA	15 GALLON
BL	25	SEVICOEBERRY	NYSSA SYRIACA	15 GALLON
	3	BLACK GUM	BETULA LENTA	15 GALLON
	11	RIVER BIRCH	BETULA VIRGINIANA	15 GALLON
	3	SWERTHAY MAGNOLIA	MAGNOLIA VIRGINIANA	15 GALLON

LANDSCAPE PLAN GENERAL NOTES

- QUANTITIES OF TREES, SHRUBS AND GRASSES, AS NOTED ON THE PLAN LIST, ARE BASED ON THE ASSUMPTIONS STATED ON THE PLAN. CONTRACTOR SHALL PROVIDE AND INSTALL THE PLANT MATERIAL, BASED UPON THE QUANTITIES LISTED IN THE PLAN LIST AND THE SYMBOLS. CONTRACTOR SHALL BE RESPONSIBLE FOR THE QUALITY OF THE PLANT MATERIAL.
- NO PLANT SUBSTITUTIONS, TREE SIZE OR QUANTITY DEVIATIONS FROM THE APPROVED LANDSCAPE PLAN SHALL BE MADE WITHOUT PRIOR APPROVAL FROM THE TOWN OF FALMOUTH.
- ALL OPEN SPACE AREAS ARE TO BE MAINTAINED BY THE HOME OWNERS ASSOCIATION.
- ALL DISTURBED AREAS SHALL BE RESTORED TO ORIGINAL CONDITION.

LEGEND

- PROPOSED BY CONTRACTOR
- PROPOSED BY OWNER
- PROPOSED BY OTHER

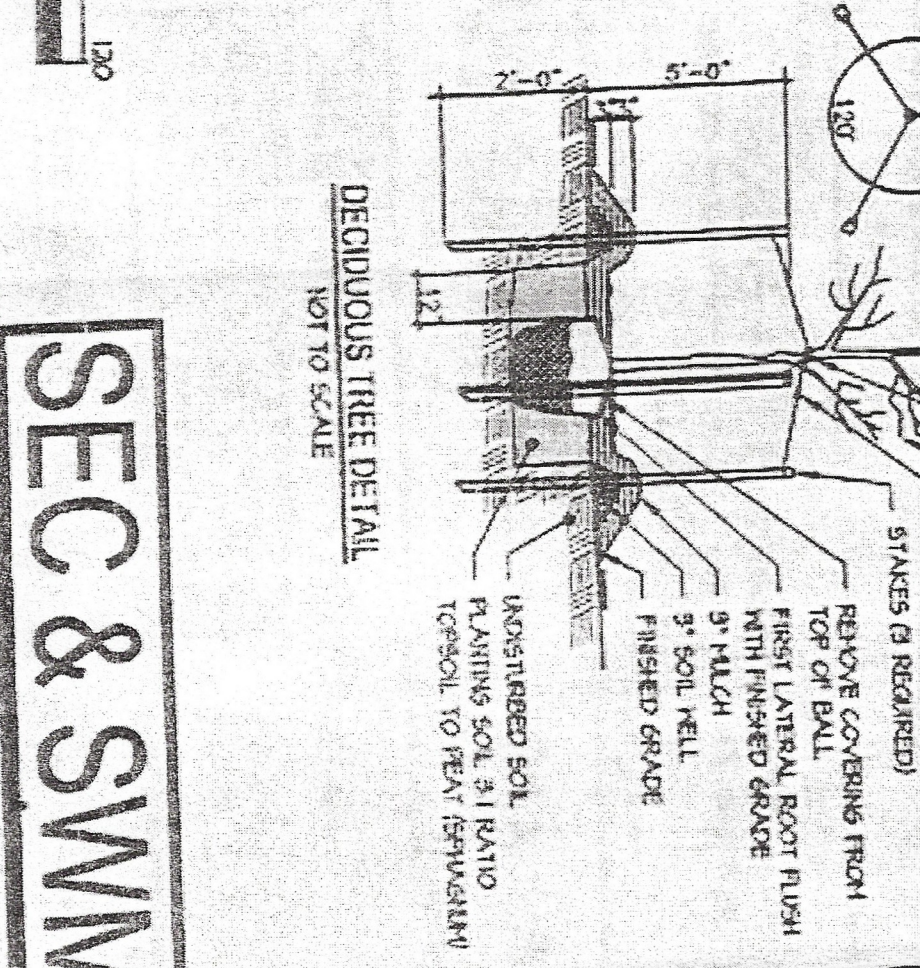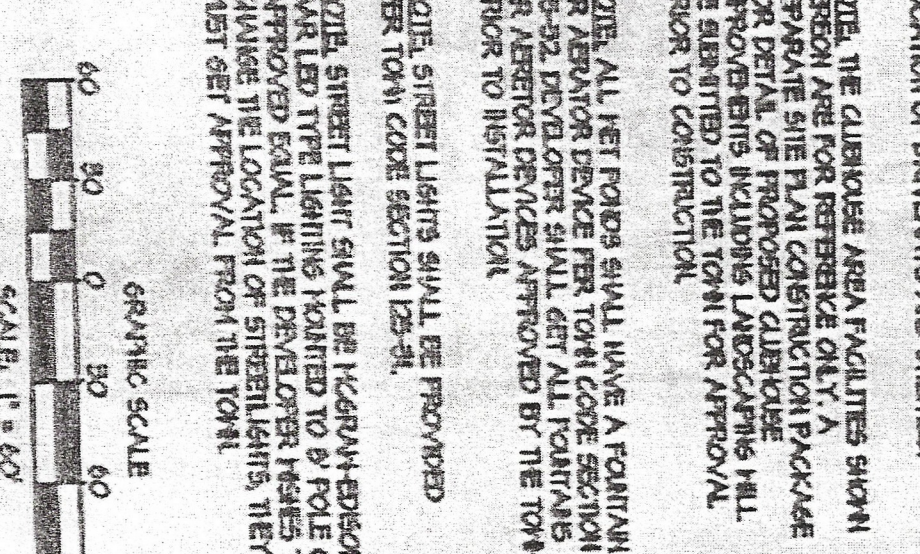

DATE	REVISIONS	DESIGNED BY	DRAWN BY	DATE

MORRIS & RITCHE ASSOCIATES, INC.
 ENGINEERS, ARCHITECTS, PLANNERS, SURVEYORS AND LANDSCAPE ARCHITECTS
 18 BOULDER CIRCLE, SUITE 26
 WASHINGTON, DE 19720
 (302) 352-2300
 (302) 352-2399
 FAX: (302) 352-2399
 MR@MRA.COM
 © 2011 MORRIS & RITCHE ASSOCIATES, INC.

LANDSCAPE AND LIGHTING PLAN
 FOR
PARKSIDE

SESSAY COAST, DEWARE
 JOB NO.: 18524
 SCALE: 1"=60'
 DATE: 2/19/19
 DESIGN BY: JPH
 REVISION BY: PLS
 SHEET 1 OF 1

NOTE: THE HOUSE, DRIVEWAY AND DRIVEWAY LOCATIONS ARE APPROVED BY THE TOWN OF FALMOUTH AND SHOWN ON THE PLAN. THE HOUSE AND DRIVEWAY LOCATIONS ARE APPROVED BY THE TOWN OF FALMOUTH AND SHOWN ON THE PLAN. THE HOUSE AND DRIVEWAY LOCATIONS ARE APPROVED BY THE TOWN OF FALMOUTH AND SHOWN ON THE PLAN.